


LONG SECTION
(SCALE (H) 1:1250 (V) 1:100)

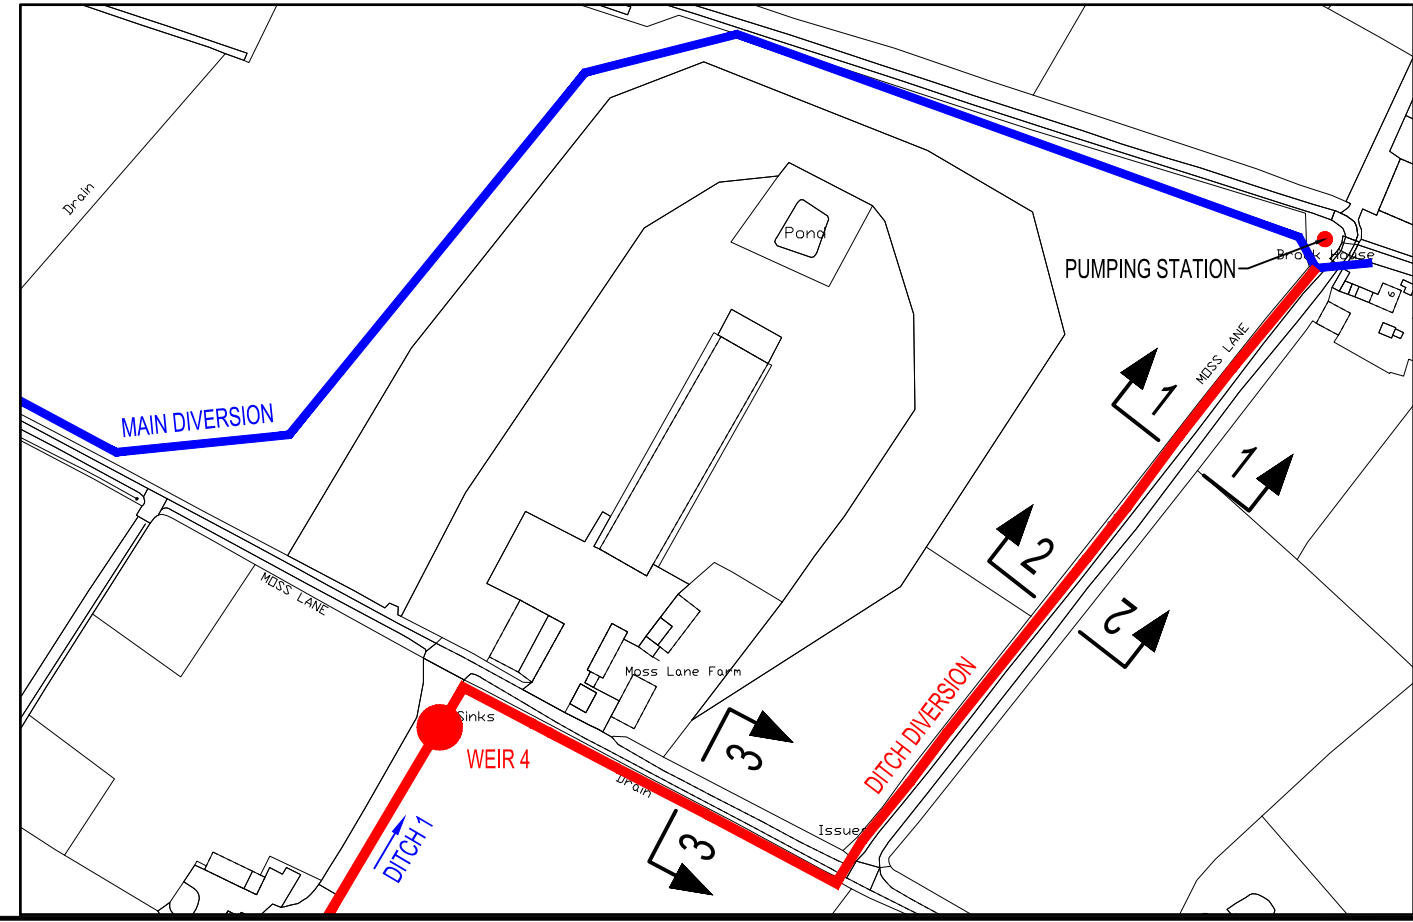

NOTE
BUNG TO BE FITTED TO 300mm Ø PIPE FORMING INLET TO PUMPED SYSTEM AT WEIR 4

Client:	NATURAL ENGLAND	
Scheme:	WORLD'S END DRAINAGE SCHEME	
Title:	DITCH 1 SITE PLAN AND LONG SECTION	
Date:	Scale:	Drawing no.
MAR. 18	AS SHOWN AT A3	C017